



NORTH

CONSULTANT:
Edge
 Consulting Engineers, Inc.
 624 WATER STREET
 PRAIRIE DU SAC, WI 53578
 608.644.1449 VOICE
 608.644.1549 FAX
 www.edgeconsult.com

CLIENT:

OVERALL GRADING PLAN
SUNSET MEMORIAL GARDEN CEMETERY
DANE COUNTY
MADISON, WISCONSIN

SHEET TITLE:

SUBMITTAL:		
INT.	DATE:	DESCRIPTION:

 

DRAWN BY	NED
CHECKED BY	BJB
PLOT DATE	12/12/2018
PROJECT NUMBER	19379
SET TYPE	PR

SHEET NUMBER **C-201**

Existing drainageway between condo buildings out to Tree Lane

Surface water flows intercepted by driveway curb and swale and redirected west to existing drainageway

Surface flow arrow

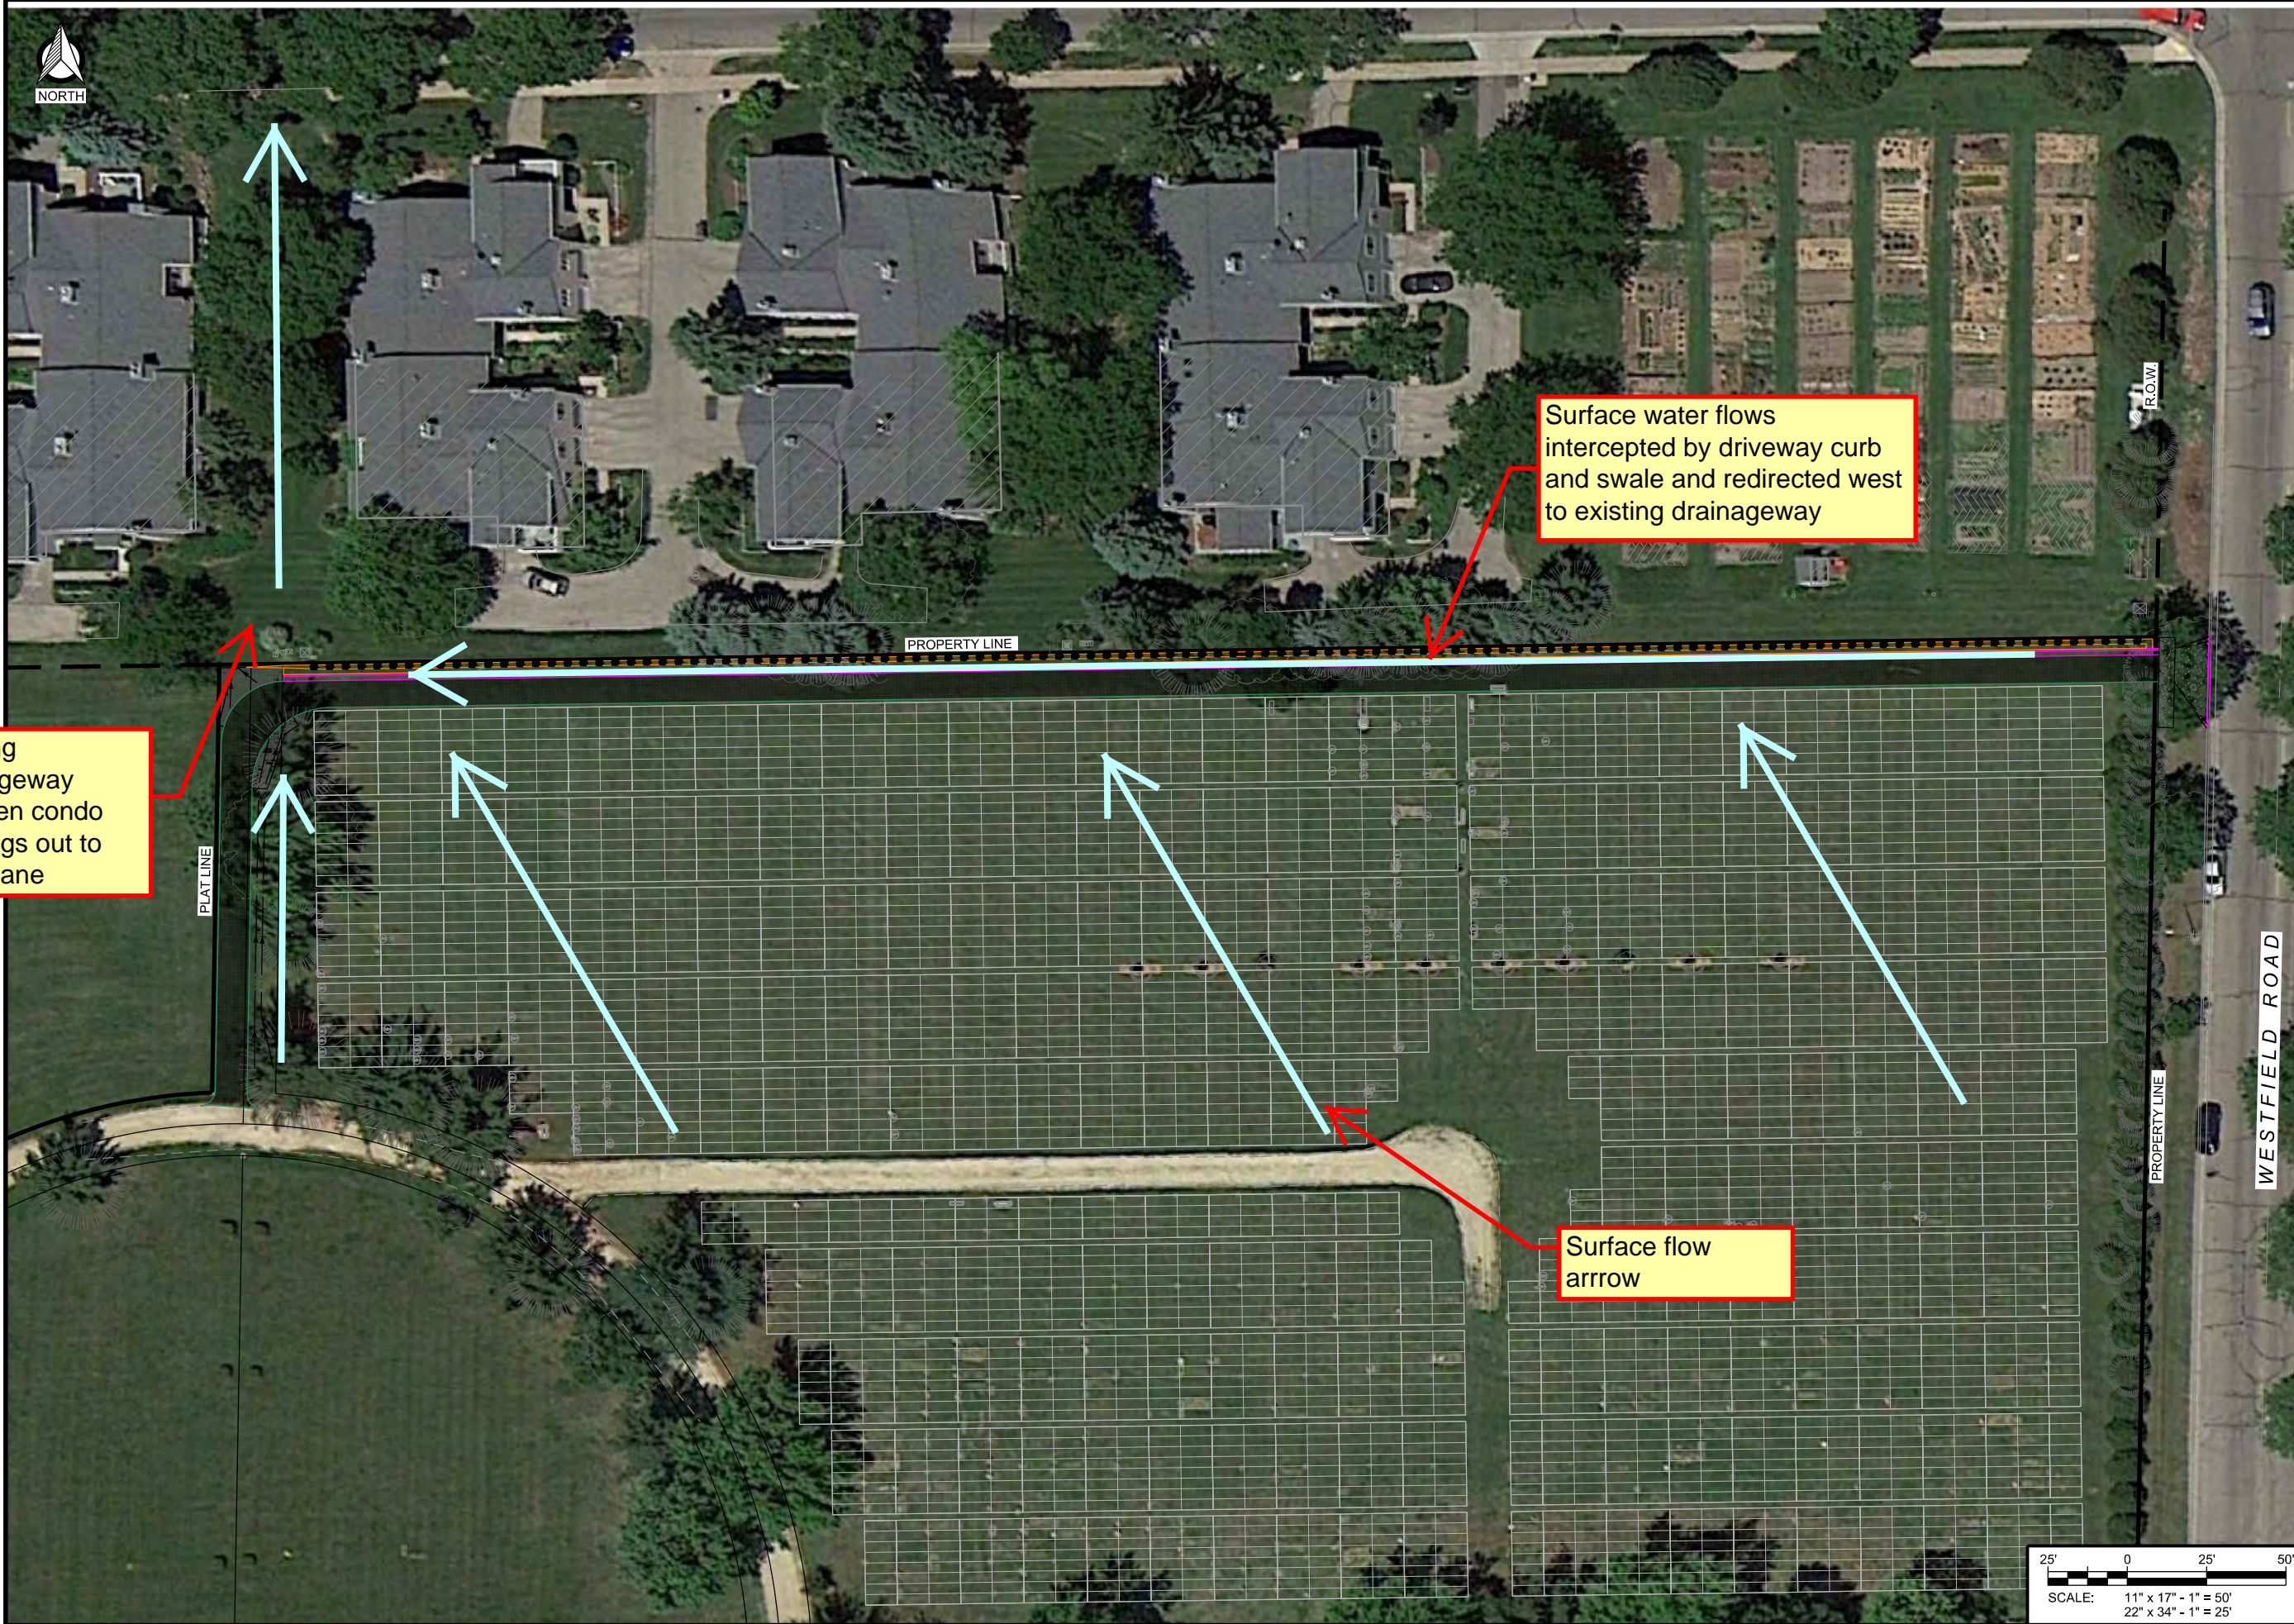

R:\193001\19379\CAD\PLAT\C-201.dgn